


DRAWING LEGEND

- A101 SITE PLAN
D201 DEMOLITION PLANS
A201 FIRST FLOOR PLAN
A202 SECOND FLOOR PLAN
A203 THIRD FLOOR/ROOF DECK PLAN


A300 ELEVATIONS
A301 FIRE ESCAPE ELEV
ME202 MECHANICAL PLAN
ME203 MECHANICAL PLAN

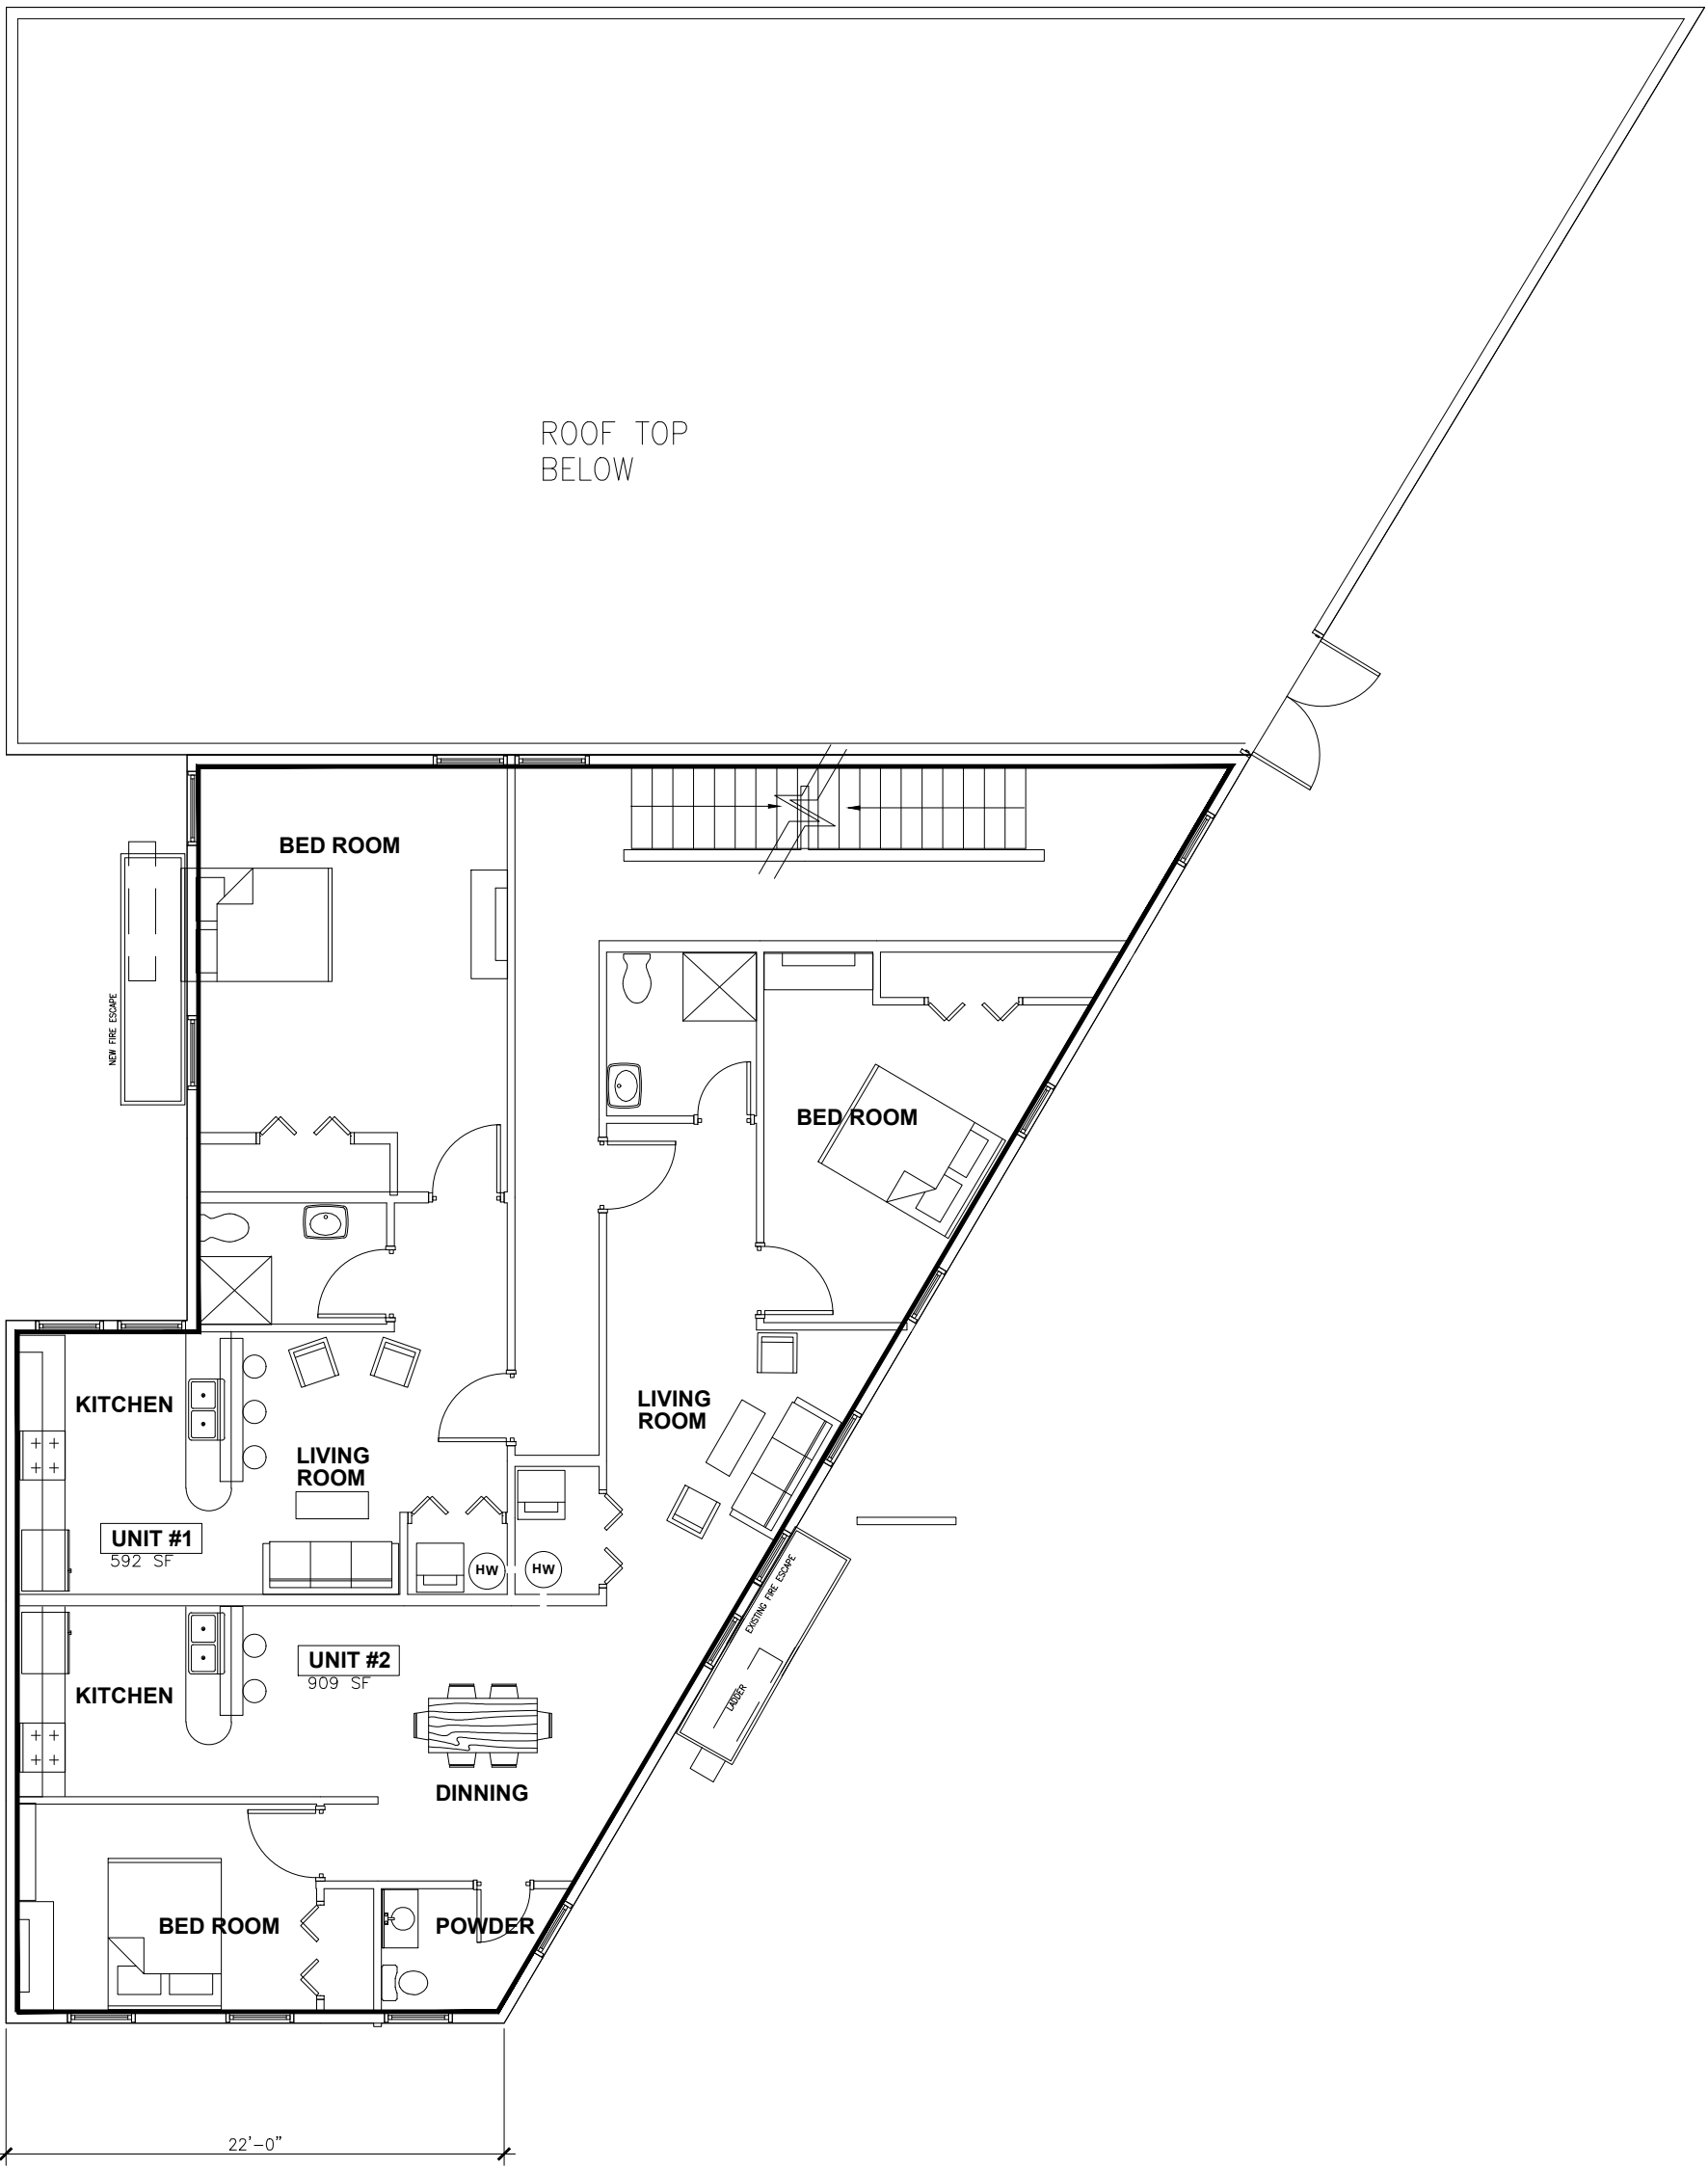

1815 SF PER FLOOR
2ND FLOOR PLAN - OPTION 4
SCALE: 1/4"=1'-0"



1815 SF PER FLOOR
3RD FLOOR PLAN - OPTION 4
SCALE: 1/4"=1'-0"

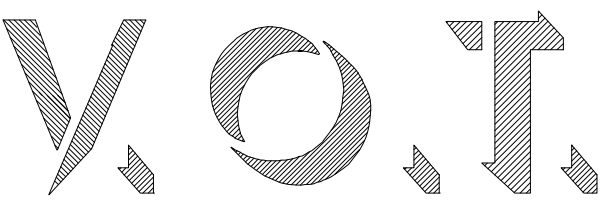

DESIGN/BUILDER & PLANNERS
4551 SOUTH SHORE DRIVE
MASON, Ohio 45040
(513) 573-9972

JAIME COOPER
MIXED USE 4 FAMILY UNITS
3341 MONTGOMERY ROAD

Cincinnati Ohio 45207

Proj. Manager
VOT
Drawn By
VOT
Checked By

Contract Date
12/28/22
Proj. Number
V111

A202