


N
M
L
K
J
H
G
F
E
D
C
B
A

1234567891011121314

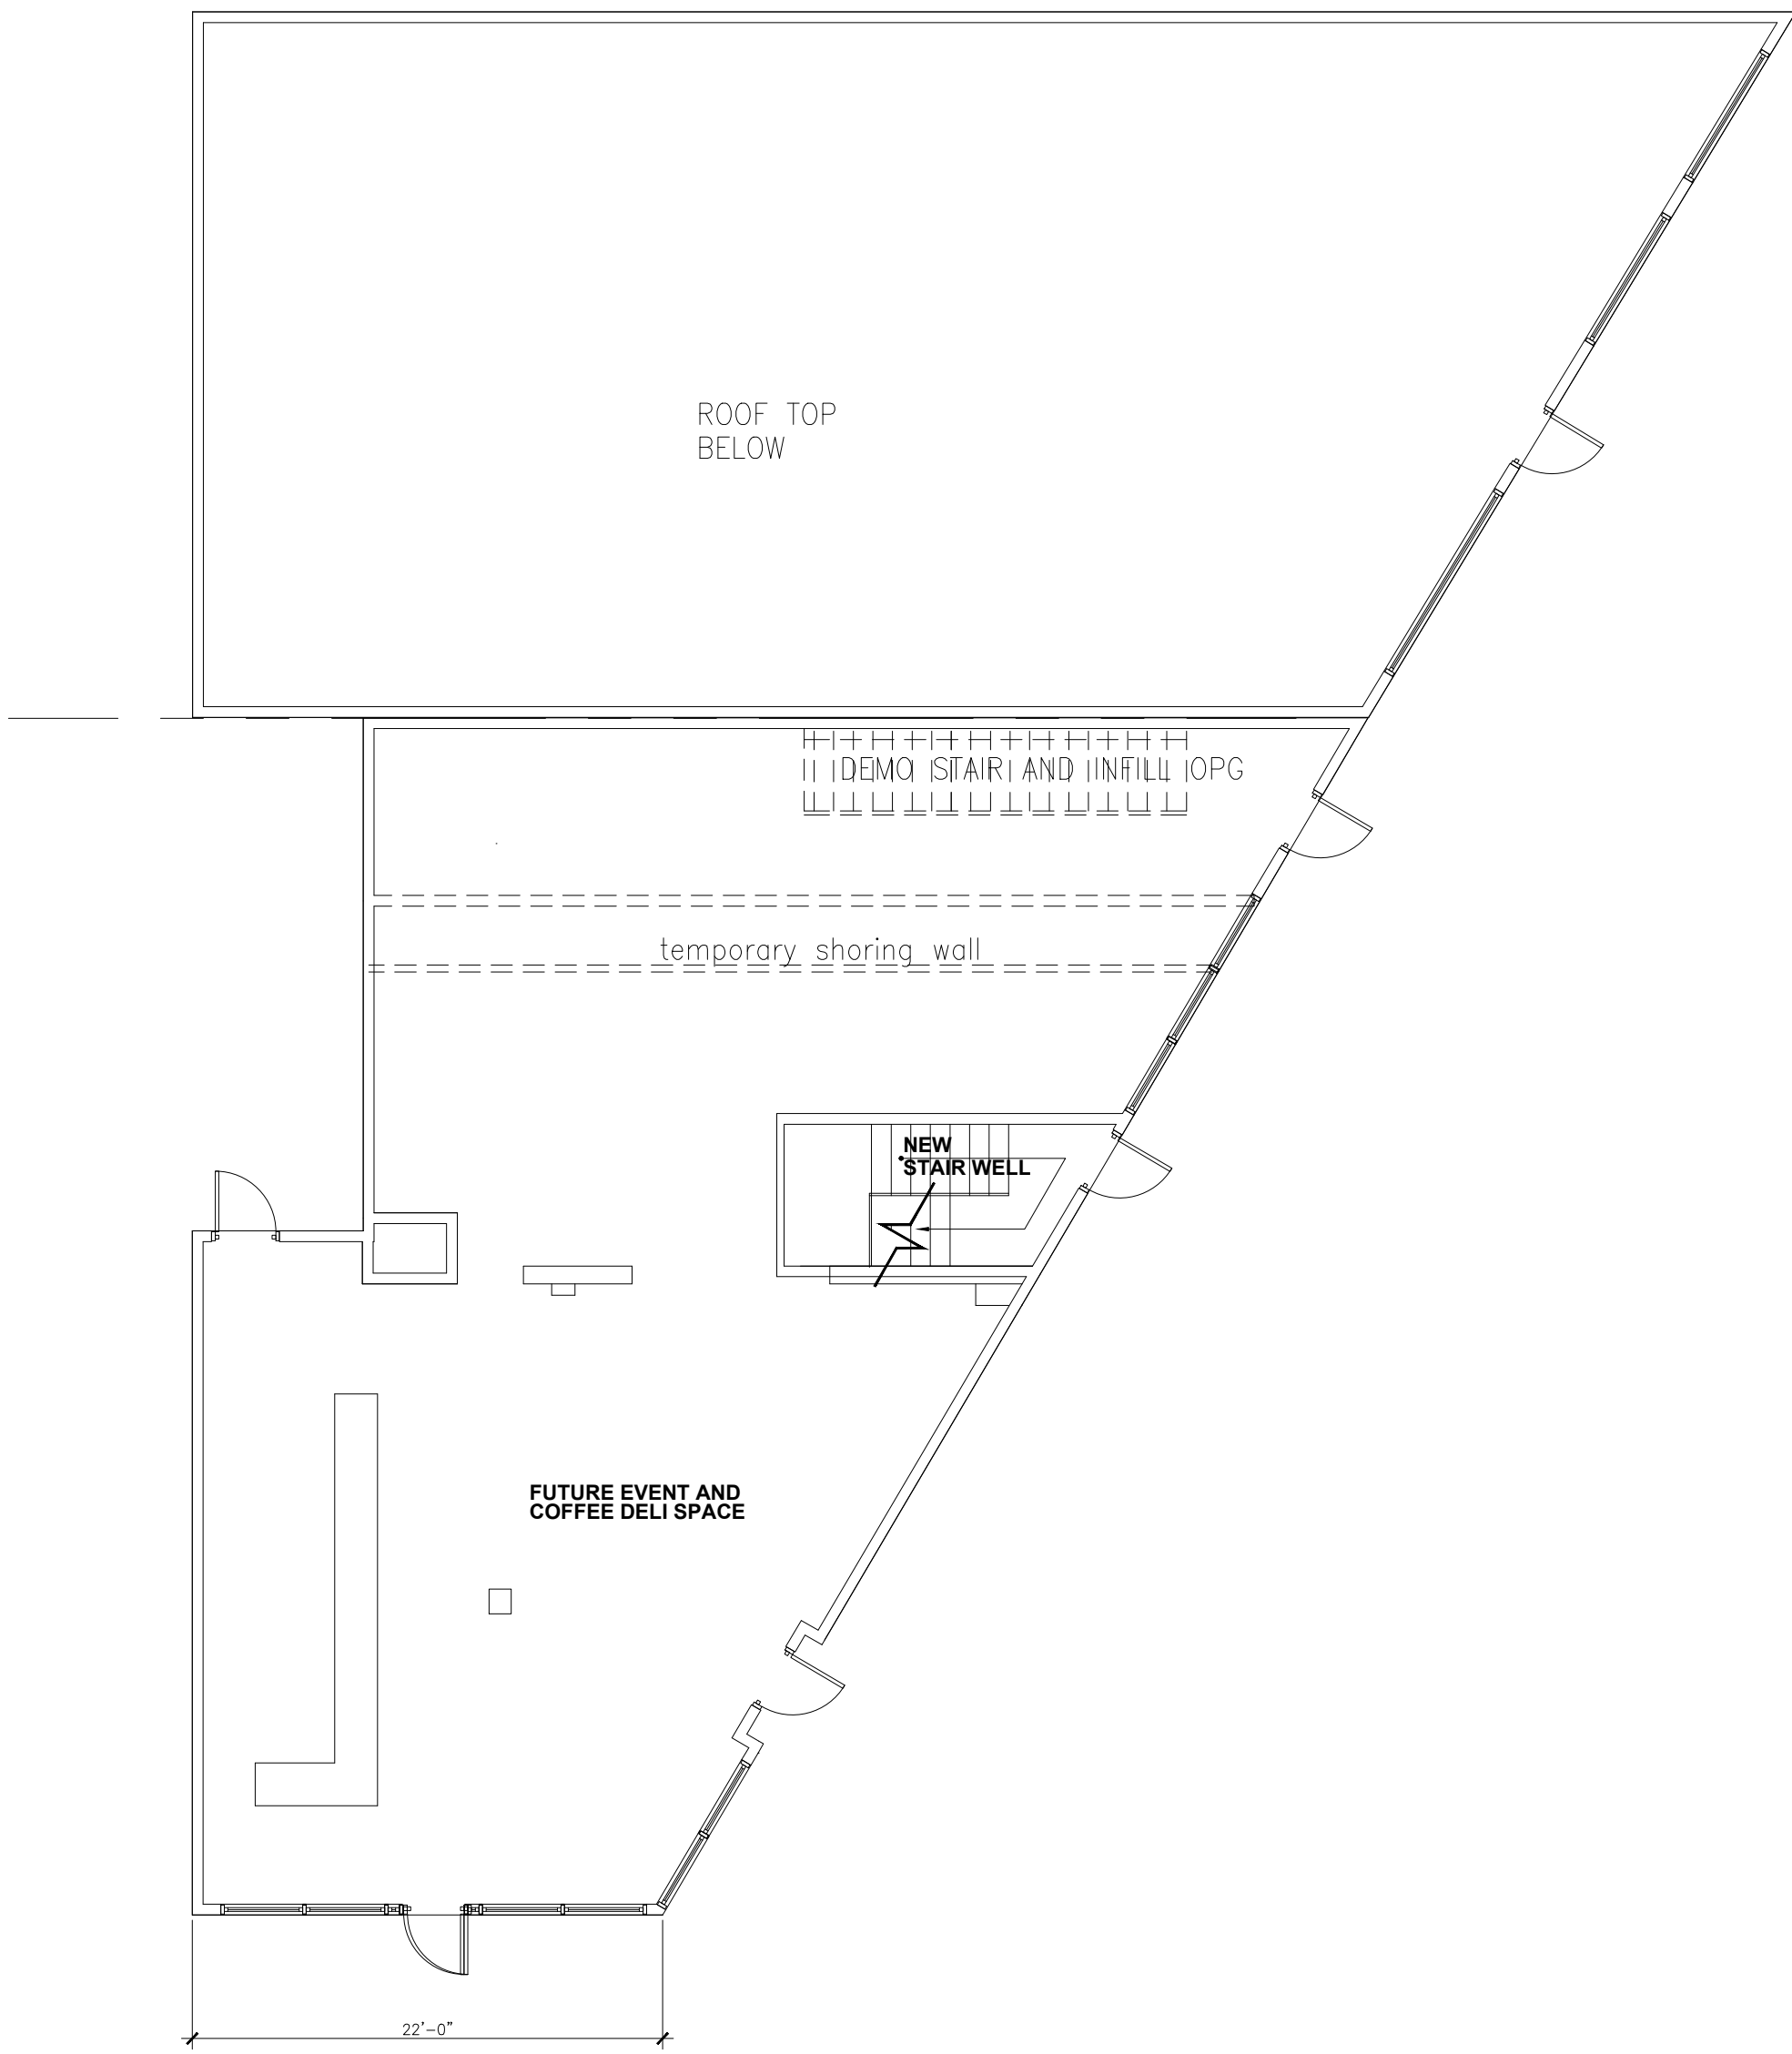


1815 SF PER FLOOR
1ST FLOOR PLAN - OPTION 4
SCALE: 1/4"=1'-0"



DRAWING NOTES THIS SHEET

DRAWING LEGEND

- A101 SITE PLAN
- D201 DEMOLITION PLANS
- A201 FIRST FLOOR PLAN
- A202 SECOND FLOOR PLAN
- A203 THIRD FLOOR/ROOF DECK PLAN
- A300 ELEVATIONS
- A301 FIRE ESCAPE ELEV
- ME202 MECHANICAL PLAN
- ME203 MECHANICAL PLAN

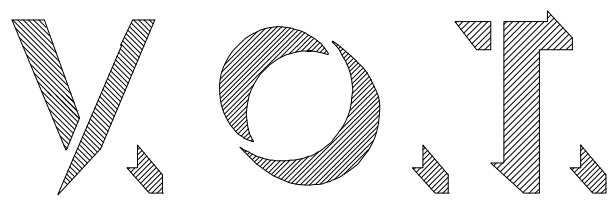

DESIGN/BUILDER & PLANNERS
4551 SOUTH SHORE DRIVE
MASON, Ohio 45040
(513) 573-9972

JAIME COOPER
MIXED USE 4 FAMILY UNITS
3341 MONTGOMERY ROAD
Cincinnati Ohio 45207

Proj. Manager
VOT
Drawn By
VOT
Checked By
Contract Date
12/28/22
Proj. Number
V111

A201

PLOT SCALE: